

TYPICAL CANDLEBERRY & BAYCREST

TYPICAL FRONT ELEVATION
SCALE: 1/4"=1'


TYPICAL HERITAGE

200300027468
JOHN T
KEATING ATTY
WOOSTER, OH

200300027468
Filed for Record in
HOLMES COUNTY OH
SALLY MILLER
11-19-2003 At 09:55 am.
SMALL PLAT 40.00
DR Book 18 Page 801 - 801

INDEXED

DRAWING SCHEDULE	
DRAWING NO.	DESCRIPTION
A1	ELEVATION DRAWINGS & DRAWING SCHEDULE
A2	ELEVATION DRAWINGS & GENERAL NOTES
A3	TYPICAL SECTION AND DETAIL DRAWINGS
A4	MAIN FLOOR PLAN
A5	FOUNDATION PLAN
A6	ROOF AND TRUSS PLAN
E1	MAIN FLOOR ELECTRICAL PLAN
E2	BASEMENT ELECTRICAL PLAN
M1	MAIN FLOOR HVAC PLAN
M2	BASEMENT HVAC PLAN
*	SITE PLAN

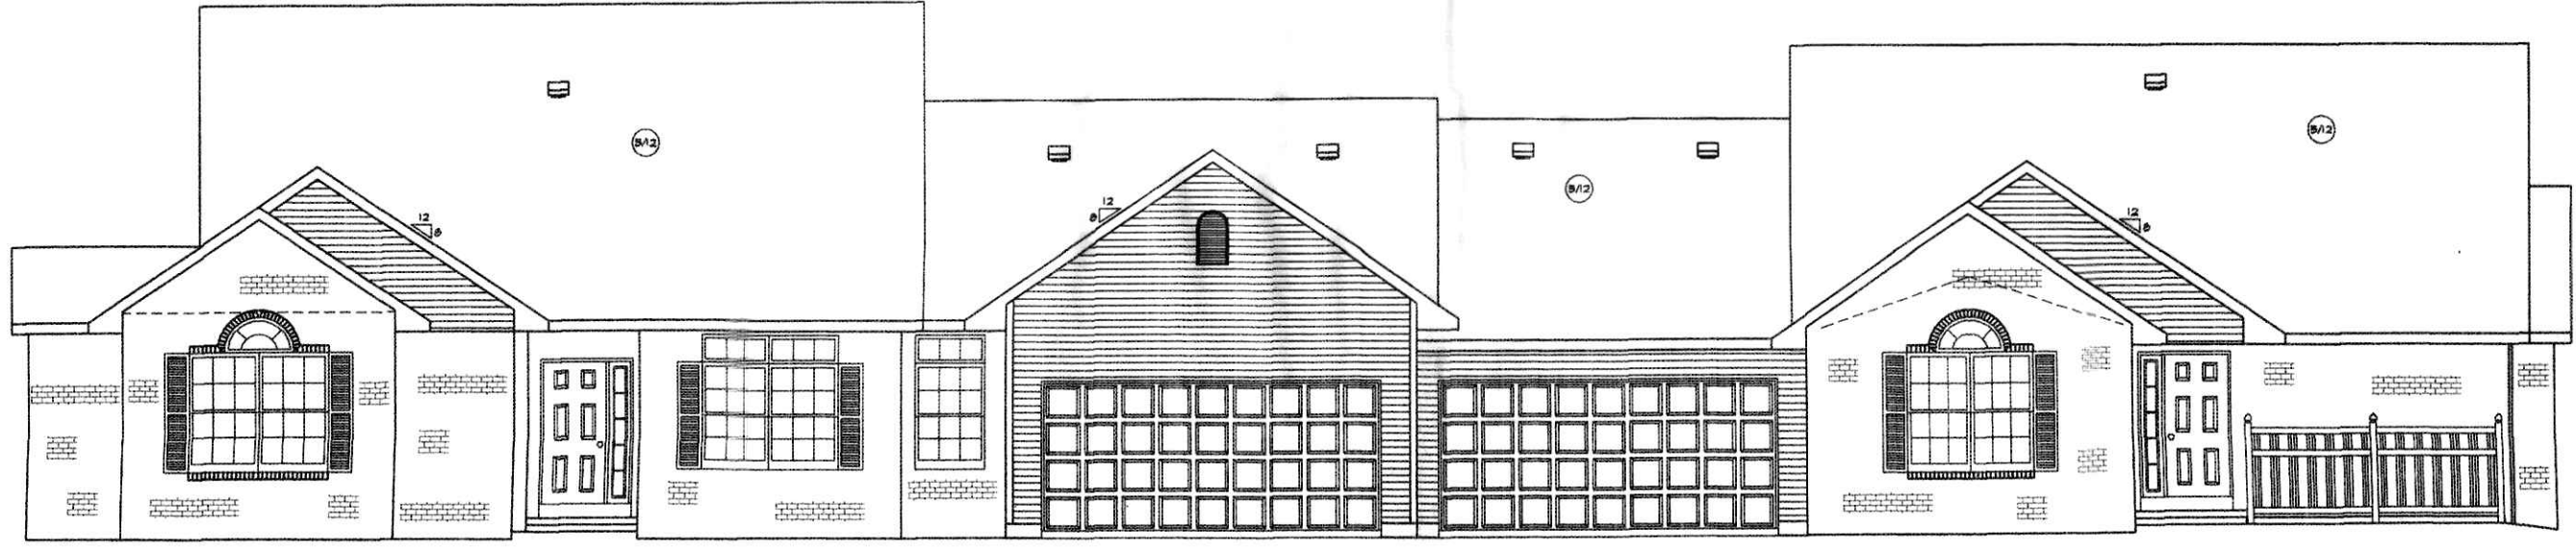

TYPICAL LEGACY

TYPICAL REAR ELEVATION
SCALE: 1/4"=1'

TYPICAL CANDLEBERRY & BAYCREST

PICKET PLACE-----BERLIN, OHIO-----FOUR UNIT CONDO

FRONT & REAR ELEVATION DRAWINGS -----SCALE: POSTED

WEAVER CUSTOM HOMES-----2171-A EAGLE PASS, WOOSTER, OHIO 44691-----((330)264-5444

