


TYPICAL CANDLEBERRY & BAYCREST

TYPICAL FRONT ELEVATION

200400032824
JOHN T KEATING ATTYS
WOOSTER, OH

200400032824
Filed for Record in
HOLMES COUNTY, OH
SALLY MILLER
09-14-2004 At 02:37 PM.
SHALL PLAT 40.00
OR Book 19 Page 181 - 181

TYPICAL HERITAGE

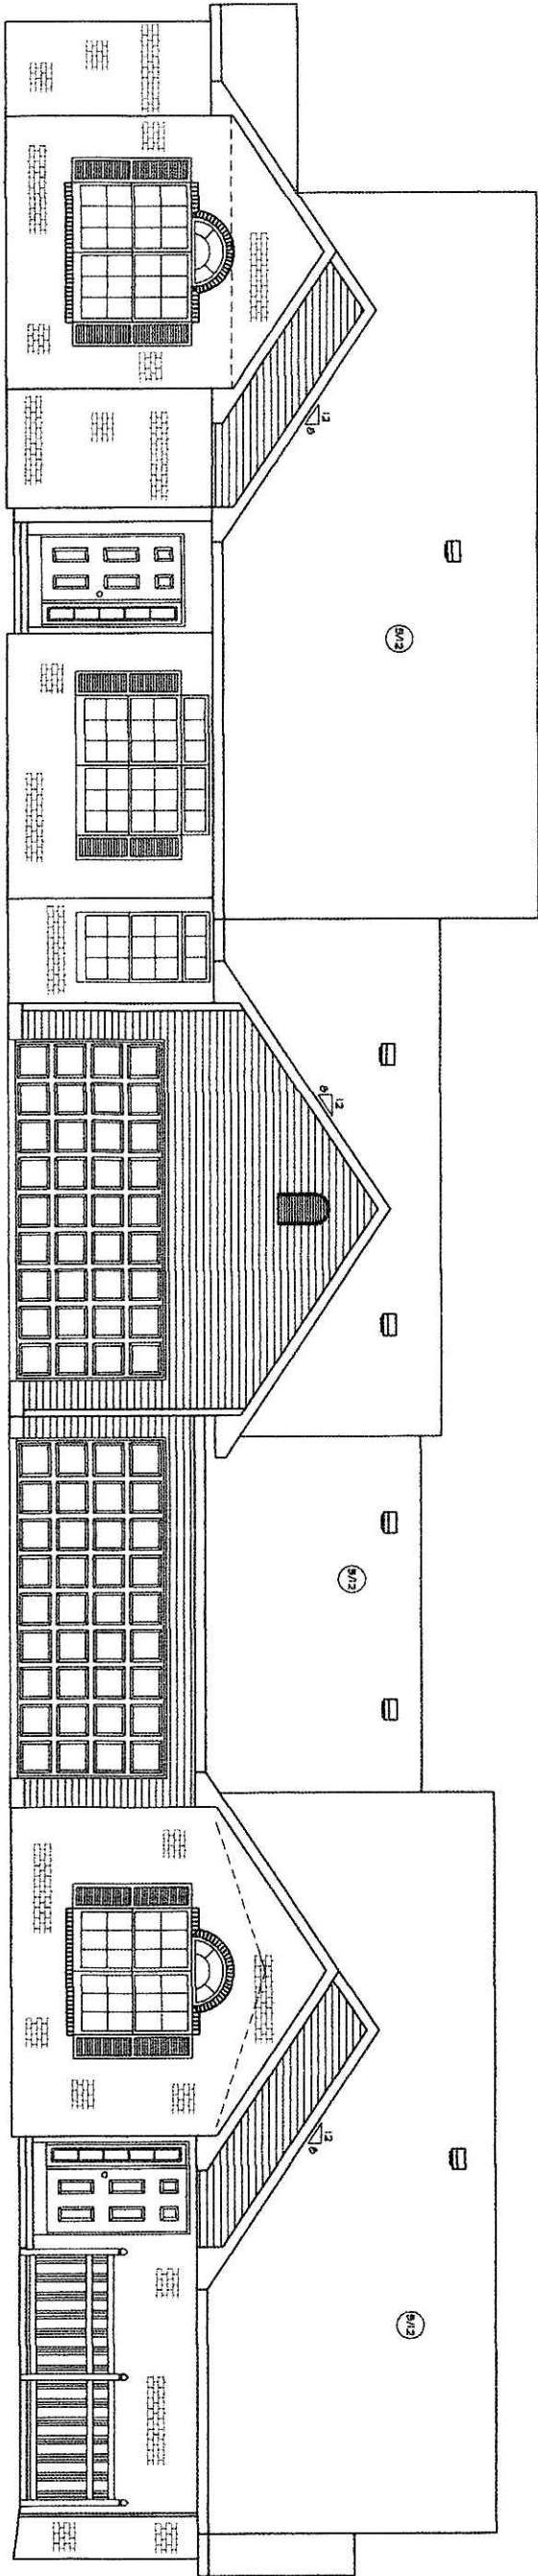

TYPICAL LEGACY

TYPICAL REAR ELEVATION

TYPICAL CANDLEBERRY & BAYCREST

DRAWING NO.	DESCRIPTION
A1	ELEVATION DRAWINGS & DRAWING SCHEDULE
A2	ELEVATION DRAWINGS & GENERAL NOTES
A3	TYPICAL SECTION AND DETAIL DRAWINGS
A4	MAIN FLOOR PLAN
A5	FOUNDATION PLAN
A6	ROOF AND TRUSS PLAN
E1	MAIN FLOOR ELECTRICAL PLAN
E2	BASEMENT ELECTRICAL PLAN
M1	MAIN FLOOR HVAC PLAN
M2	BASEMENT HVAC PLAN
P1	MAIN FLOOR PLUMBING DRAINAGE PLAN
P2	BASEMENT PLUMBING DRAINAGE PLAN
P3	PLUMBING ISOMETRIC
P4	MAIN FLOOR PLUMBING SUPPLY PLAN
P5	BASEMENT PLUMBING SUPPLY PLAN
S	SITE PLAN

URL 001910181

PICKET PLACE-----BERLIN, OHIO-----FOUR UNIT CONDO

FRONT & REAR ELEVATION DRAWINGS -----SCALE: POSTED

WEAVER CUSTOM HOMES-----2171-A EAGLE PASS, WOOSTER, OHIO 44691----- (330)264-5444